

WT/UCB / SINK - Room 4
SIZE - 1275 x 900
SCHEDULE ITEM NO:35(a)

WT/UCB / SINK - Room 11
SIZE - 2400 x 900
SCHEDULE ITEM NO:35(b)

WT / UCB / SINK UNIT ELEVATION
FURNITURE Fittings For UCB one unit
two shutters


FURNITURE Fittings For UCB one unit
one shutters

- 1. 75mm SS Cut Hinges - 2Nos.
- 2. SS Handle 100mm "D" Type - 1No.
- 3. Pad lock - 1No.
- 4. Magnatic Catch - 2Nos.

- 1. 75mm SS Cut Hinges - 4Nos.
- 2. SS Handle 100mm "D" Type - 2Nos.
- 3. Pad lock - 1No.
- 4. Magnatic Catch - 3Nos.
- 5. 75mm SS Tower Bolt - 1No.

WINDOW A/C- 1050X1000mm -W
Schedule item no: 33(a)

Furniture Fittings:-
 1. M.S.Holdfast 150x50x6mm - 4nos.

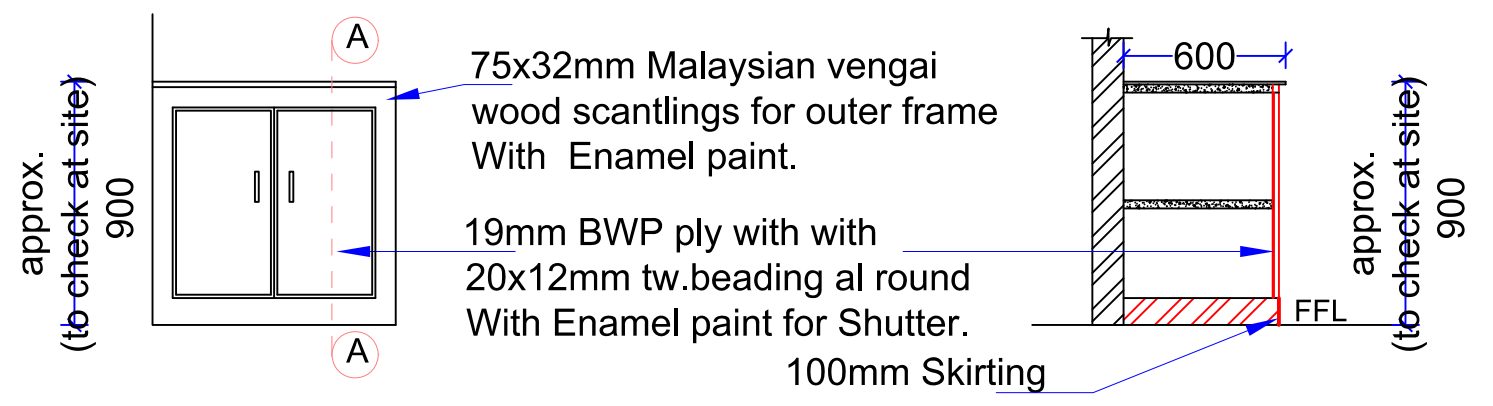

UCB- Room 18,19 & 20
SIZE - 1575 x 900
SCHEDULE ITEM NO: 35(c)

FURNITURE Fittings For UCB one unit
two shutters

- 1. 75mm SS Cut Hinges - 4Nos.
- 2. SS Handle 100mm "D" Type - 2Nos.
- 3. Pad lock - 1No.
- 4. Magnatic Catch - 3Nos.
- 5. 75mm SS Tower Bolt - 1No.

NOTE:

1. All dimensions are in mm.
2. All fittings are of ISI make. unless otherwise mentioned.
3. All wood are free from knots & whites of first quality
4. 1.5mm planning tolerance on each wrought face is permitted.
5. All sizes mentioned are approximate to suit site conditions and as per actual measurements.
6. All exposed teak wood beadings are to be polished with sheenlac french polishing to a satisfactory finish.
7. Approved make of MDF boards - duratuff exterior grade or equivalent make.
8. PAYMENT WILL BE MADE SEPARATELY
9. Dimensions should be Re-checked at site.
10. Work to figured Dimensions, Do not scale this drawing.
11. Discrepancies if any should be brought to the notice of the engineer.
12. Approved make of Aluminium sections - Jindal / approved equivalent make.
13. All Aluminium sections to be anodised to a minimum thk. of 5 microns of natural colour matt finish.

TENDER PURPOSE ONLY

CHRISTIAN MEDICAL COLLEGE -VELLORE.		
MODIFICATION TO EXISTING DENTAL OPD IN FIRST FLOOR OF MAIN OPD BLOCK AT CMC TOWN CAMPUS		
DENTAL OPD FIRST FLOOR PLAN: JOINERY DETAILS		
CHKD BY: DEVAKI.G	DATE : 29.08.2024	PLANNING ENGINEER:
DRAWN: NESSA	DRG.NO:CMC/OPD/J-002	